


PLAN
SCALE: 1"=50'-0"

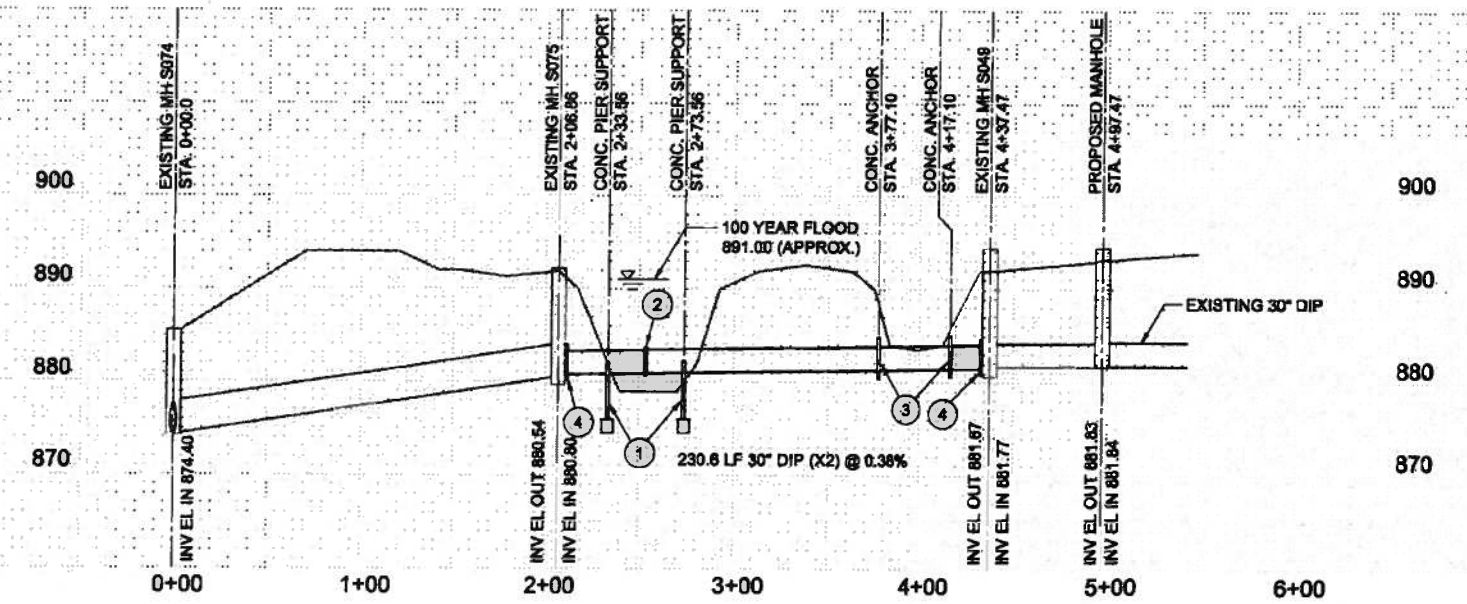

BROWN AND CALDWELL
Environmental Engineers and Consultants
990 Hammond Drive, Suite 400, Atlanta, Georgia 30328 770-394-2397
SUBMITTED: _____ DATE: _____
APPROVED: _____ DATE: _____

LINE IS 2 INCHES AT FULL SIZE (IF NOT 2" SCALE ACCORDINGLY)
DESIGNED: R WILLIAMS
DRAWN: J PORTER
CHECKED: N MIRAI
CHECKED: R WILLIAMS
APPROVED: _____

EXTERNAL REFERENCE FILES
134314-2-Border.dwg



REVISIONS				
ZONE	REV.	DESCRIPTION	BY	DATE
	1	REMOVED ABANDONING OF 24\"/>		

DEKALB COUNTY DEPARTMENT OF WATERSHED MANAGEMENT
HERITAGE HEIGHTS REPAIR

42" SEWER LINE REPLACEMENT
PLAN AND PROFILE

FILENAME: 134314-C-02
BC PROJECT NUMBER: 134314
CLIENT PROJECT NUMBER:
DRAWING NUMBER: C 02
SHEET NUMBER OF